


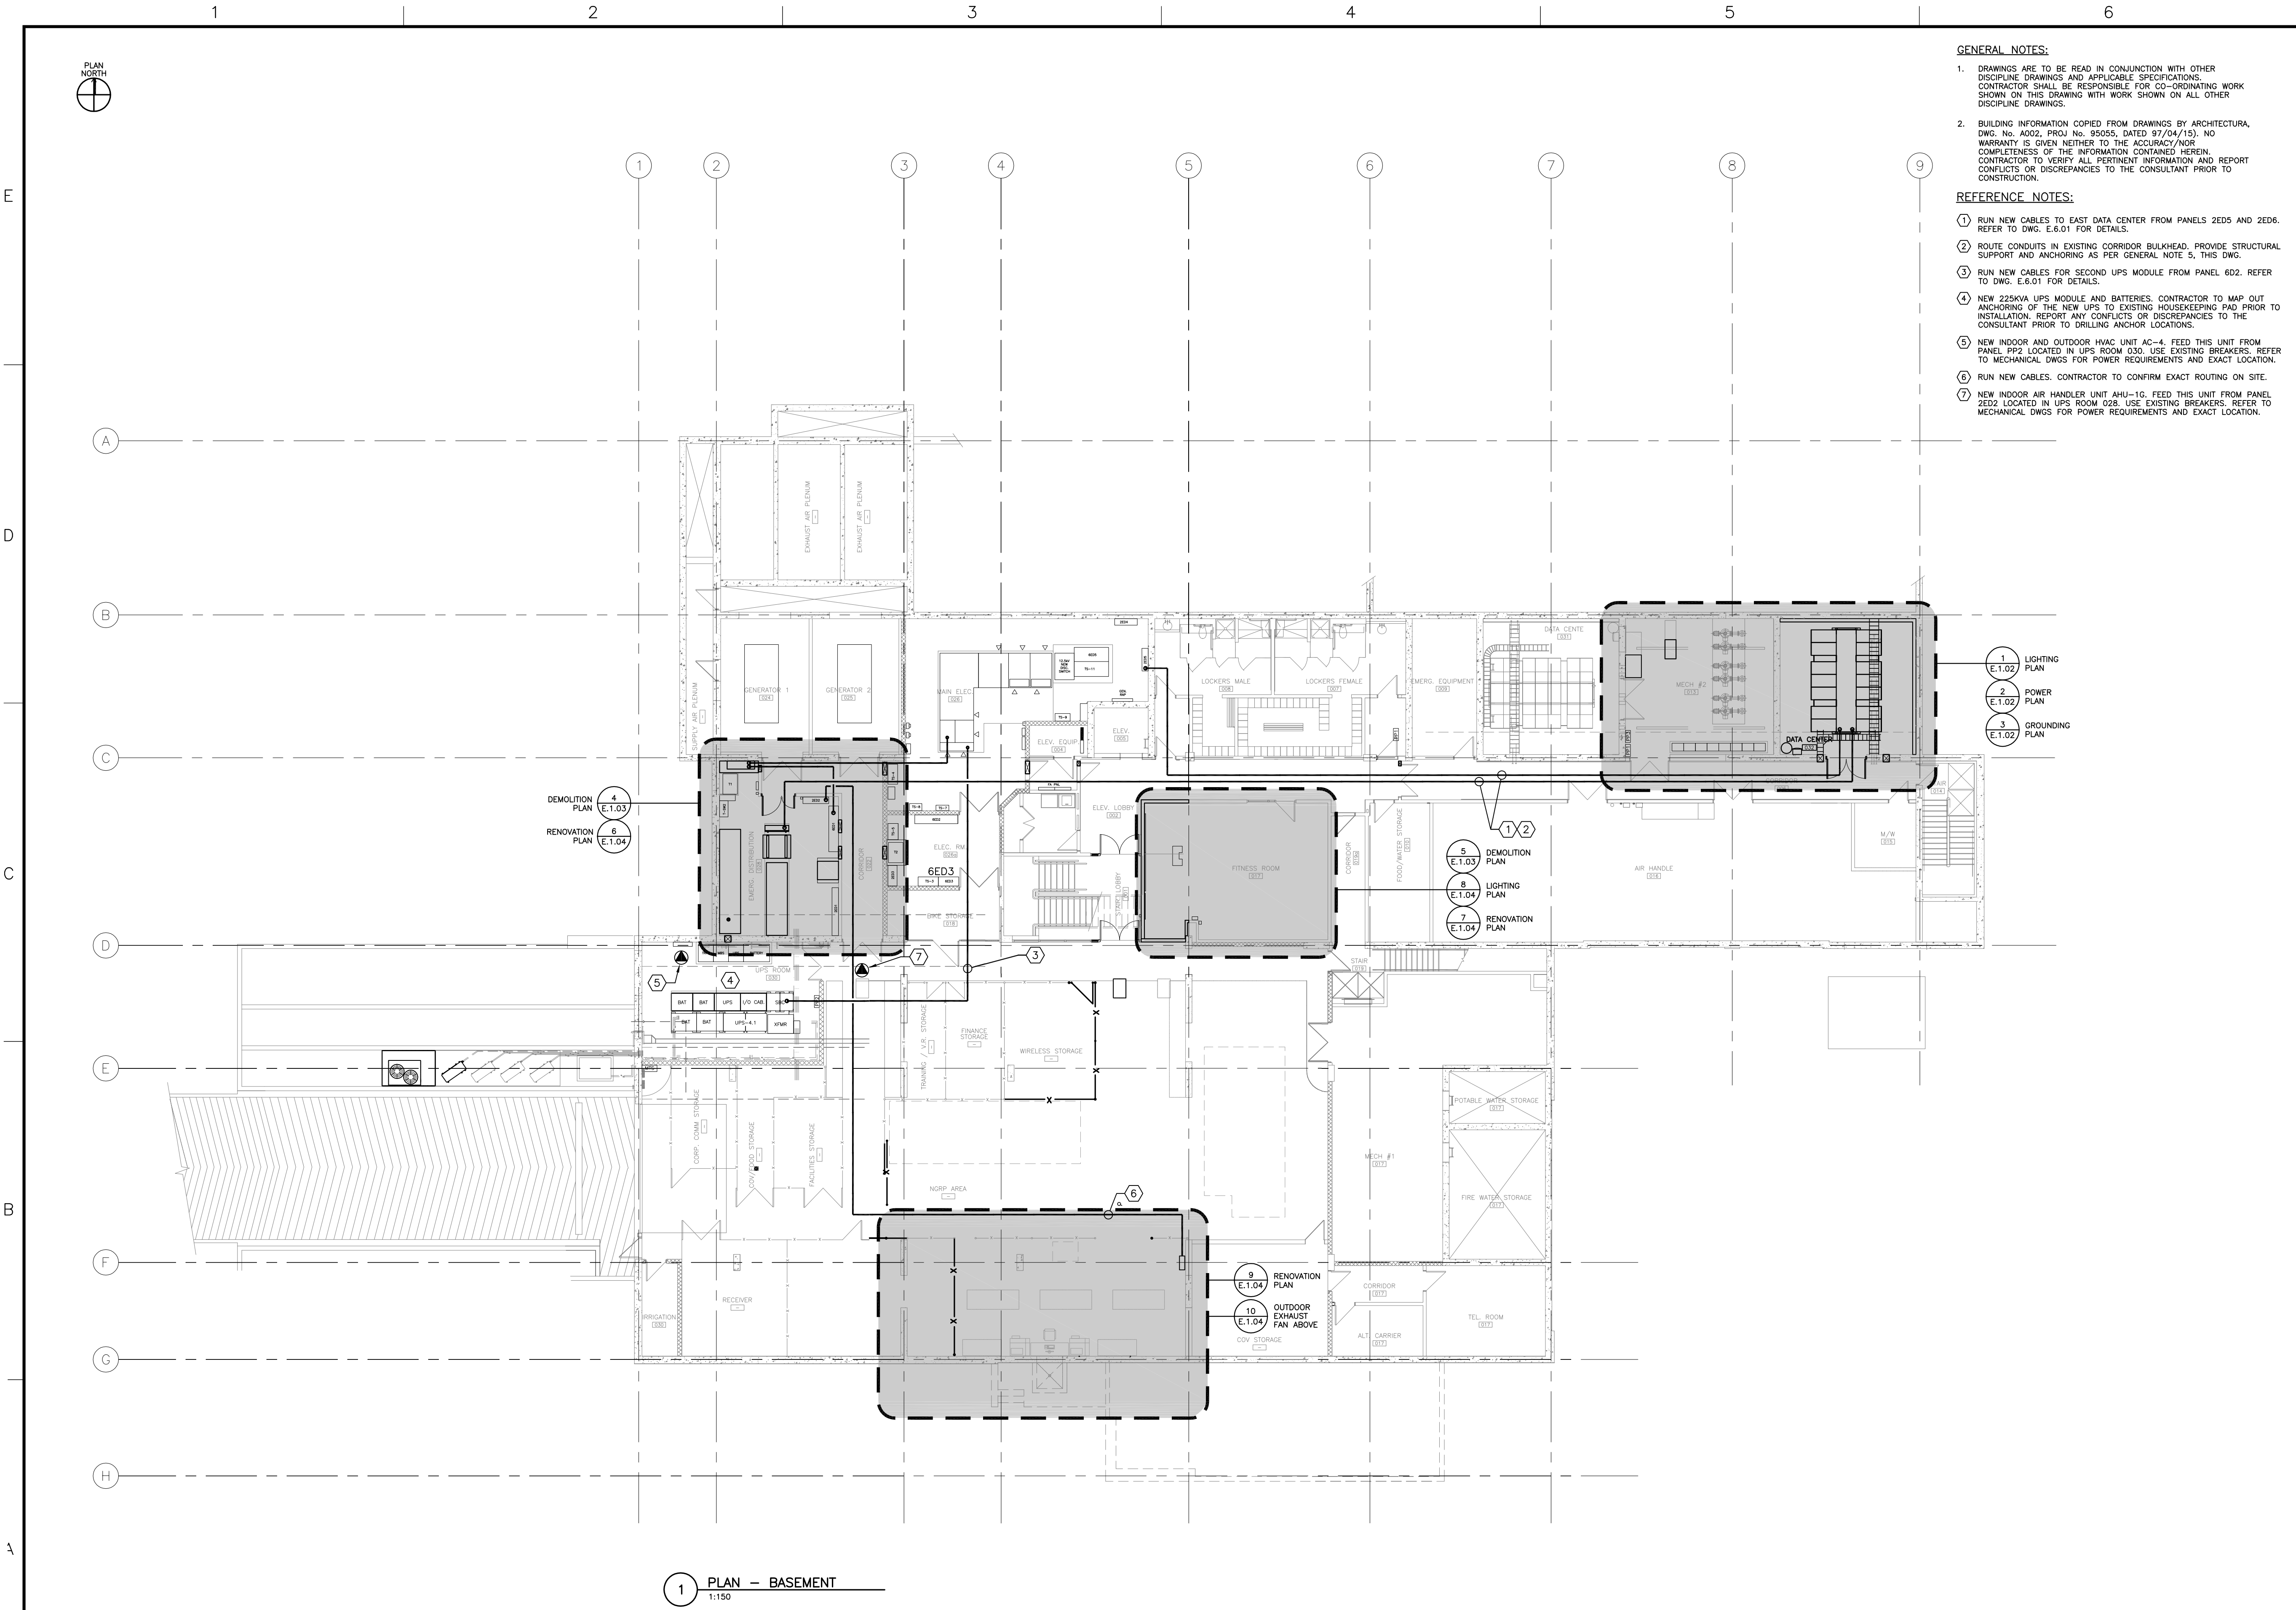

- GENERAL NOTES:**
- DRAWINGS ARE TO BE READ IN CONJUNCTION WITH OTHER DISCIPLINE DRAWINGS AND APPLICABLE SPECIFICATIONS. CONTRACTOR SHALL BE RESPONSIBLE FOR CO-ORDINATING WORK SHOWN ON THIS DRAWING WITH WORK SHOWN ON ALL OTHER DISCIPLINE DRAWINGS.
 - BUILDING INFORMATION COPIED FROM DRAWINGS BY ARCHITECTURA, DWG. No. A002, PROJ. No. 95055, DATED 97/04/15). NO WARRANTY IS GIVEN NEITHER TO THE ACCURACY/NOR COMPLETENESS OF THE INFORMATION CONTAINED HEREIN. CONTRACTOR TO VERIFY ALL PERTINENT INFORMATION AND REPORT CONFLICTS OR DISCREPANCIES TO THE CONSULTANT PRIOR TO CONSTRUCTION.
- REFERENCE NOTES:**
- RUN NEW CABLES TO EAST DATA CENTER FROM PANELS 2ED5 AND 2ED6. REFER TO DWG. E.6.01 FOR DETAILS.
 - ROUTE CONDUITS IN EXISTING CORRIDOR BULKHEAD. PROVIDE STRUCTURAL SUPPORT AND ANCHORING AS PER GENERAL NOTE 5, THIS DWG.
 - RUN NEW CABLES FOR SECOND UPS MODULE FROM PANEL 6D2. REFER TO DWG. E.6.01 FOR DETAILS.
 - NEW 225KVA UPS MODULE AND BATTERIES. CONTRACTOR TO MAP OUT ANCHORING OF THE NEW UPS TO EXISTING HOUSEKEEPING PAD PRIOR TO INSTALLATION. REPORT ANY CONFLICTS OR DISCREPANCIES TO THE CONSULTANT PRIOR TO DRILLING ANCHOR LOCATIONS.
 - NEW INDOOR AND OUTDOOR HVAC UNIT AC-4. FEED THIS UNIT FROM PANEL PP2 LOCATED IN UPS ROOM 030. USE EXISTING BREAKERS. REFER TO MECHANICAL DWGS FOR POWER REQUIREMENTS AND EXACT LOCATION.
 - RUN NEW CABLES. CONTRACTOR TO CONFIRM EXACT ROUTING ON SITE.
 - NEW INDOOR AIR HANDLER UNIT AHU-1G. FEED THIS UNIT FROM PANEL 2ED2 LOCATED IN UPS ROOM 028. USE EXISTING BREAKERS. REFER TO MECHANICAL DWGS FOR POWER REQUIREMENTS AND EXACT LOCATION.

1 PLAN -- BASEMENT
1:150

- 1 LIGHTING PLAN
E.1.02
- 2 POWER PLAN
E.1.02
- 3 GROUNDING PLAN
E.1.02

- 5 DEMOLITION PLAN
E.1.03
- 8 LIGHTING PLAN
E.1.04
- 7 RENOVATION PLAN
E.1.04

- 9 RENOVATION PLAN
E.1.04
- 10 OUTDOOR EXHAUST FAN ABOVE
E.1.04